
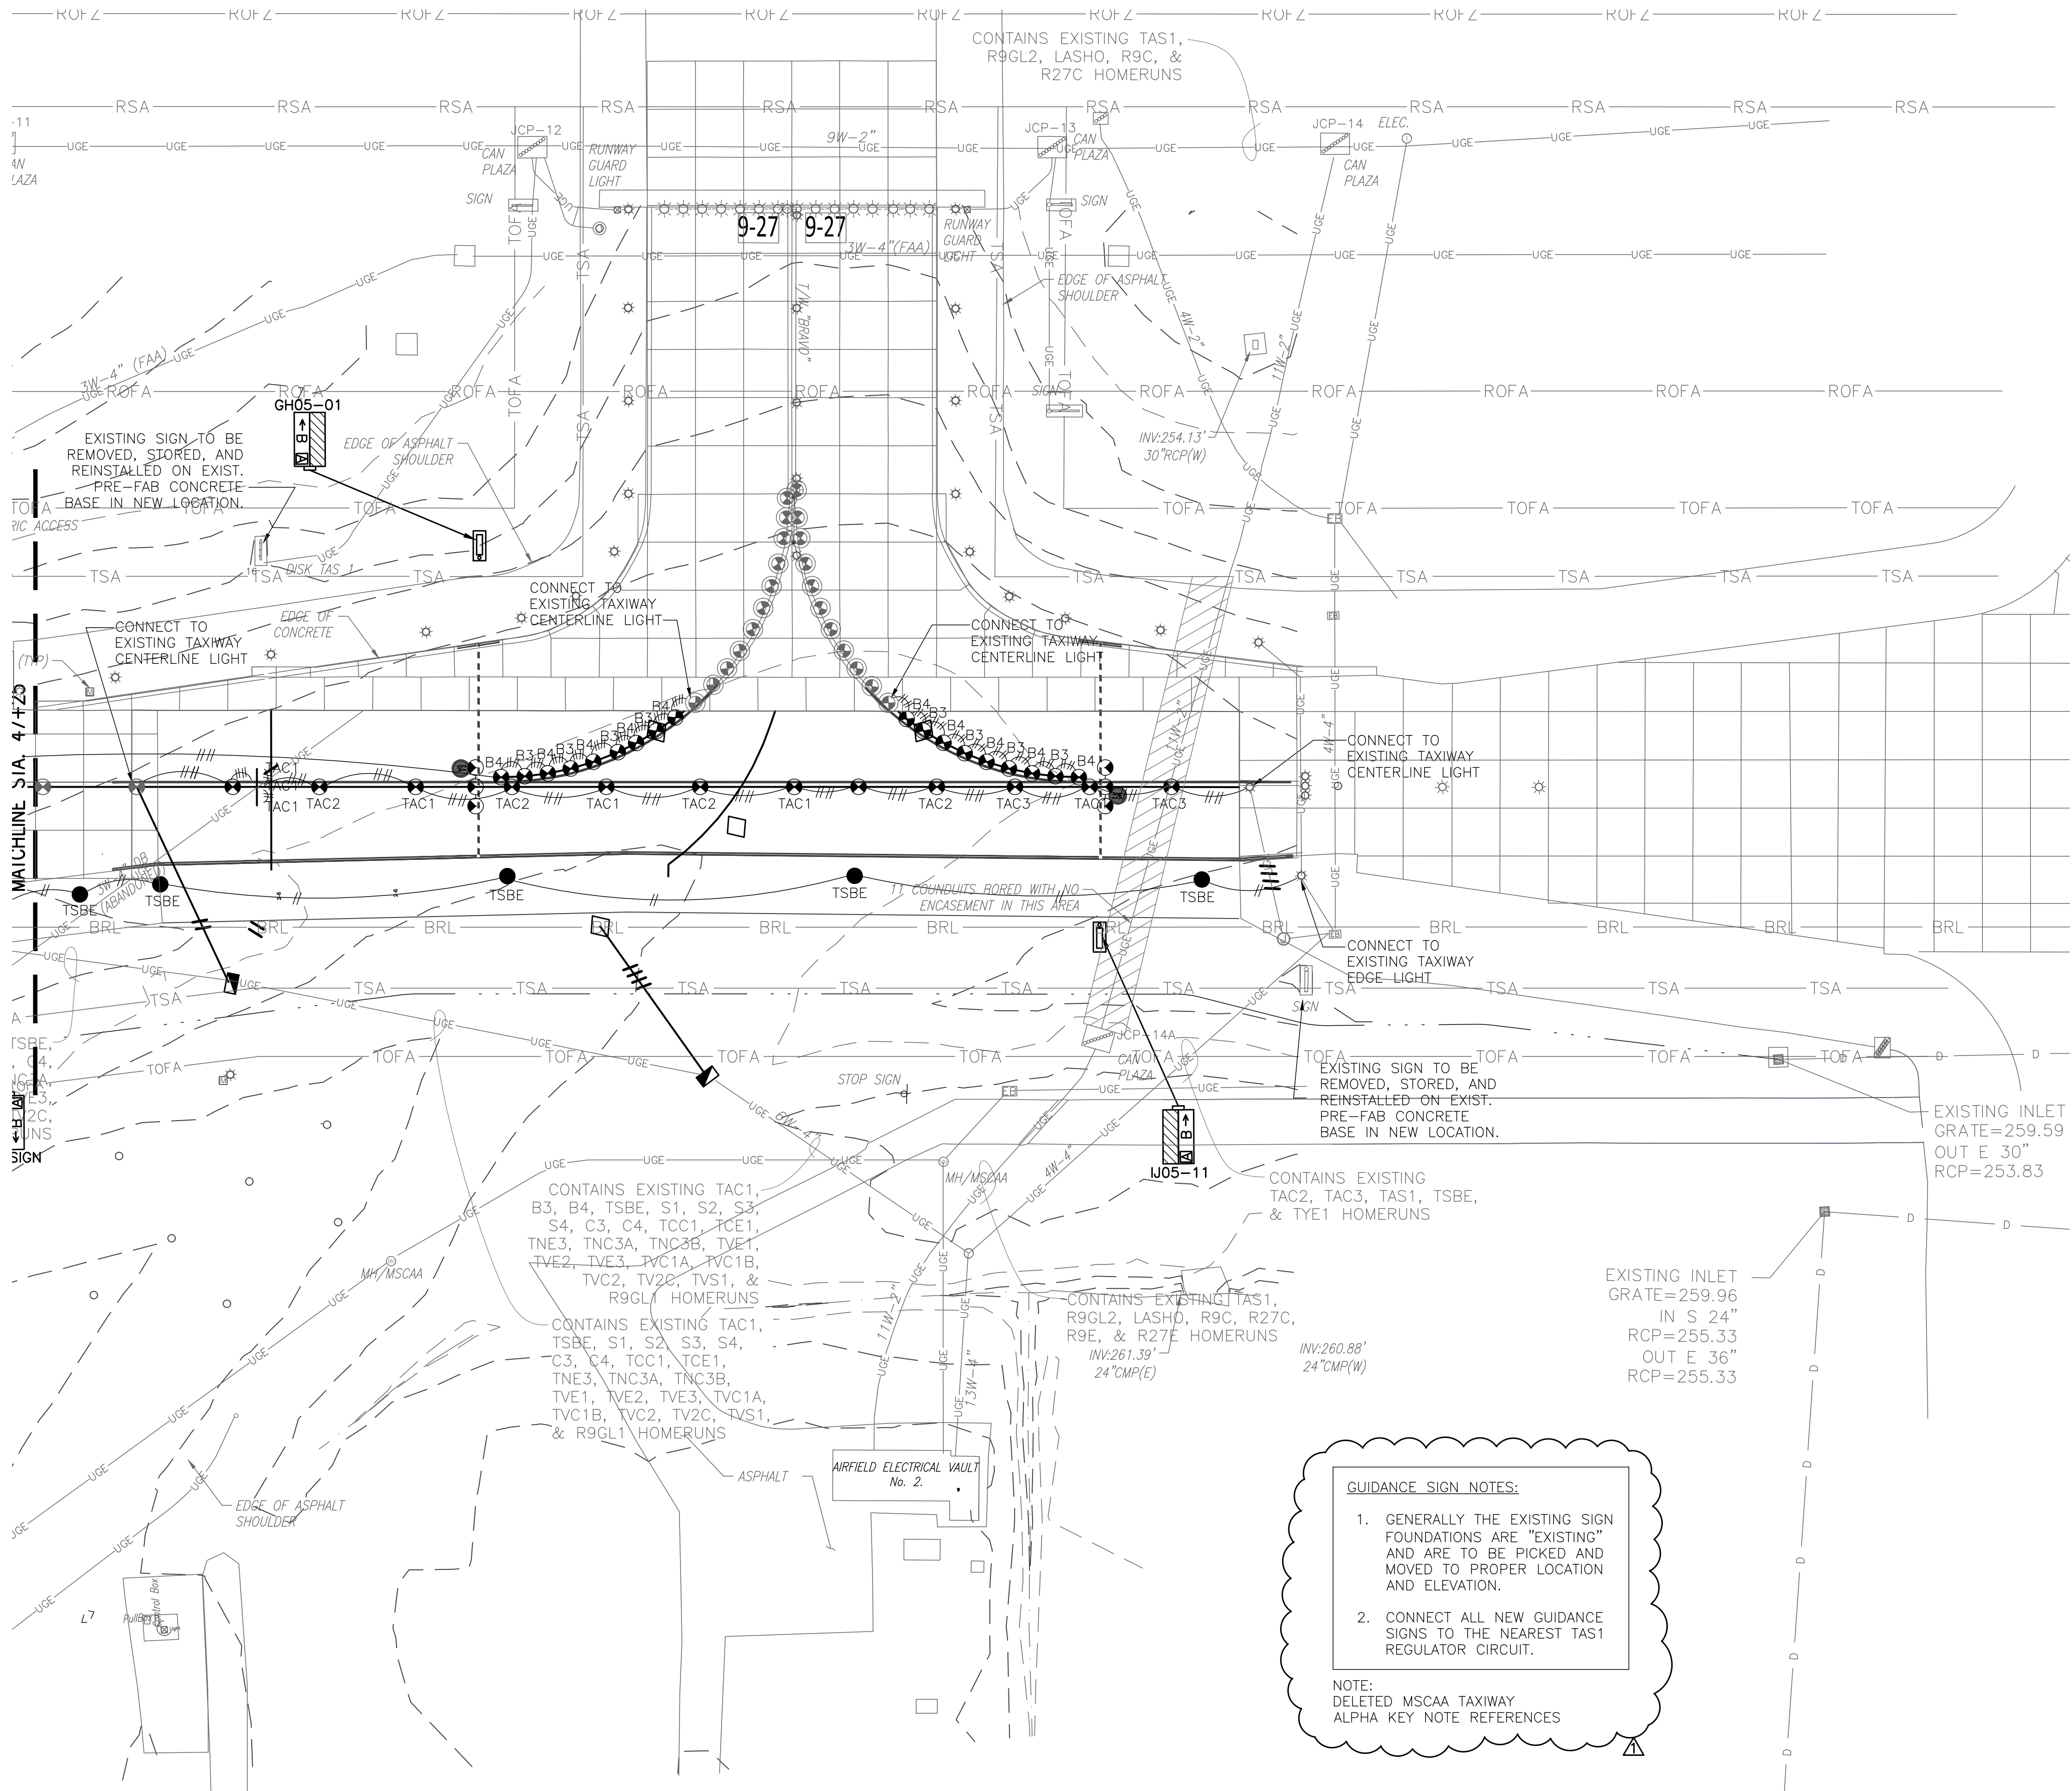


NOTES

- SEE SHEET E-LT-00 FOR LEGEND.
- REFER TO SHEET E-DT-08 FOR LIGHTING FIXTURE COORDINATE LOCATIONS.

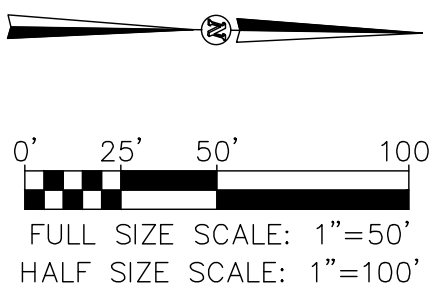

GUIDANCE SIGN NOTES:

- GENERALLY THE EXISTING SIGN FOUNDATIONS ARE "EXISTING" AND ARE TO BE PICKED AND MOVED TO PROPER LOCATION AND ELEVATION.
- CONNECT ALL NEW GUIDANCE SIGNS TO THE NEAREST TAS1 REGULATOR CIRCUIT.

NOTE:  
DELETED MSCAA TAXIWAY  
ALPHA KEY NOTE REFERENCES



MEMPHIS INTERNATIONAL AIRPORT  
2491 WINCHESTER RD., SUITE 113  
MEMPHIS, TENNESSEE  
38116-3856

PROGRAM MANAGER

**PARSONS**  
Program Management Consultant

Parsons Transportation  
Group Inc.  
Project Office:  
4225 Airways Blvd.  
Memphis TN 38116  
JOB NO.



1661 INTERNATIONAL DRIVE  
SUITE 100  
MEMPHIS, TENNESSEE 38120  
PHONE: 901-820-0820  
FAX: 901-863-1001

JOB NO. 72198-B

ENGINEER-SUBCONSULTANT



50 Monroe Avenue  
Suite 420  
Memphis, TN 38103  
Tel: 901.543.8000  
JOB NO.

DRAWN BY:


RNP

CHECKED BY:

HP

APPROVED BY:

TG

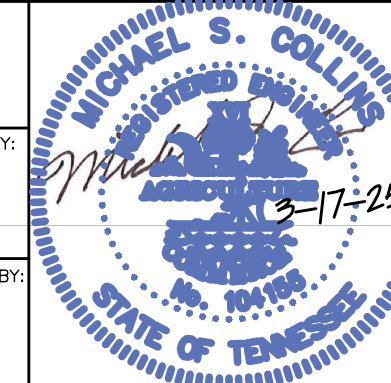

This information is released solely for its use in the interest of the Memphis-Shelby County Airport Authority (MSCAA) or its tenants.  
All drawings received from MSCAA as a work product shall be regarded as privileged information, not to be released to others without the express written permission of MSCAA.

Your acceptance of the released materials establishes your understanding of, and commitment to, providing adequate control of the materials issued and produced.

ISSUED FOR BID

| NO.       | DESCRIPTION | DATE    | BY |
|-----------|-------------|---------|----|
| 1         | ADDENDUM 2  | 7/10/25 | JB |
| REVISIONS |             |         |    |

PROJECT:

**TAXIWAY BRAVO  
RECONFIGURATION  
(HOT SPOT 1)**

SHEET TITLE:

**LIGHTING PLAN  
TAXIWAY ALPHA  
STA. 47+25.00 TO  
STA. 53+50.00**

MSCAA NO.

**18-1413-03**

DWG. FILE NAME

**E-LT-02.DWG**

DATE

**03/17/2025**

SCALE

**1"=50'**

FACILITY NO.

**NONE**

DWG NO.

**E-LT-02**

SHEET NO.